

PROPOSED LIGHTNING ROD

PROPOSED VERIZON WIRELESS DUAL BAND RRH UNIT LOCATED BEHIND ANTENNAS (2/SECTOR-6 TOTAL)

PROPOSED VERIZON WIRELESS C-BAND ANTENNA/RRH (1/SECTOR-3 TOTAL)

PROPOSED VERIZON WIRELESS ANTENNA (2/SECTOR-6 TOTAL)

184' OVERALL HEIGHT OF STRUCTURE


180' TOP OF PROPOSED MONOPOLE

175' ϕ PROPOSED VERIZON WIRELESS ANTENNAS

PROPOSED MAXIMUM LENGTH MONOPOLE (DESIGNED BY OTHERS)

EXISTING GRADE

1 ELEVATION
 SCALE: 1" = 20' (11x17 SIZE)
 1" = 10' (22x34 SIZE)

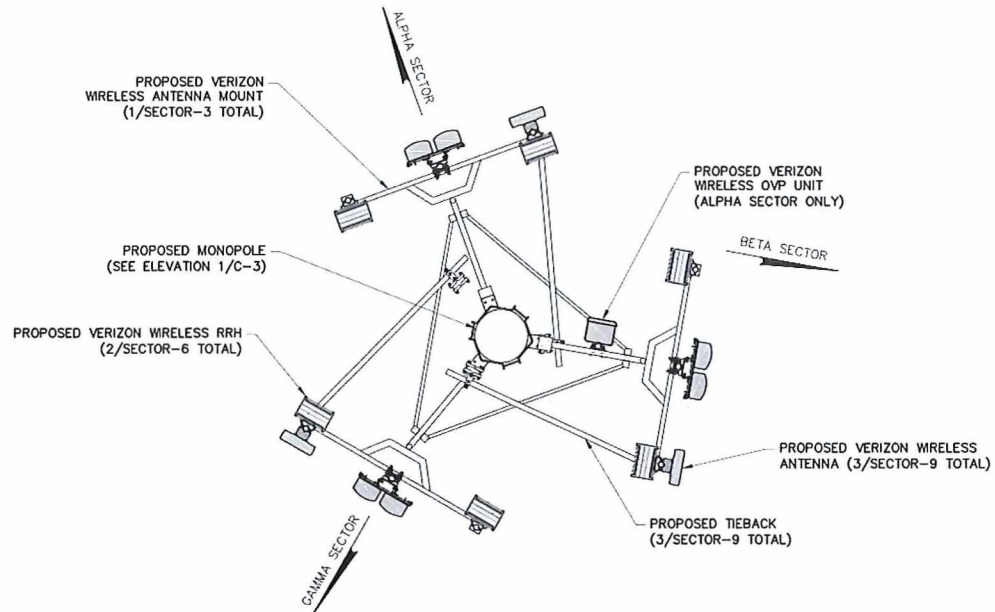

2 ANTENNA ORIENTATION
 SCALE: 3/16" = 1'-0" (11x17 SIZE)
 3/8" = 1'-0" (22x34 SIZE)



1275 JOHN STREET, SUITE 100
 WEST HENRIETTA, NY 14586



Practical Solutions. Exceptional Service.
 Technical Engineering Consultants, Geologic & Land Surveying, E.P.C.
 28 Empire American Blvd. Phone: (518) 788-4533
 Suite 100 West Henrietta, NY 14586 Fax: (518) 787-6531
 www.tectonicengineering.com

WORK ORDER NUMBER 11272.075 DRAWN BY MO

NO. DATE ISSUE
 0 8/1/24 FOR PERMIT

NO.	DATE	ISSUE
0	8/1/24	FOR PERMIT

RELEASED BY DATE



UNAUTHORIZED ALTERATION OR ADDITIONS TO A PLAN BEARING THE SEAL OF A LICENSED ENGINEER OR LAND SURVEYOR IS A VIOLATION OF SECTION 2209 SUBDIVISION 2 OF THE NEW YORK STATE EDUCATION LAW.

COPIES OF THIS DOCUMENT WITHOUT A FACSIMILE OF THE SIGNATURE AND AN ORIGINAL EMBOSSED SEAL OR ORIGINAL STAMP IN BLUE OR RED INK OF THE PROFESSIONAL ENGINEER OR LAND SURVEYOR SHALL NOT BE CONSIDERED VALID COPIES.



ORIGINAL SIZE IN INCHES


SITE INFORMATION
 AURIESVILLE
 FUZE PN: 17134169
 MDC#: 5000012652

SITE ADDRESS
 200 CLARK DRIVE
 TOWN OF GLEN
 MONTGOMERY COUNTY
 NY 12072

SHEET TITLE
 ELEVATION
 & ORIENTATION PLAN

SHEET NUMBER

C-3

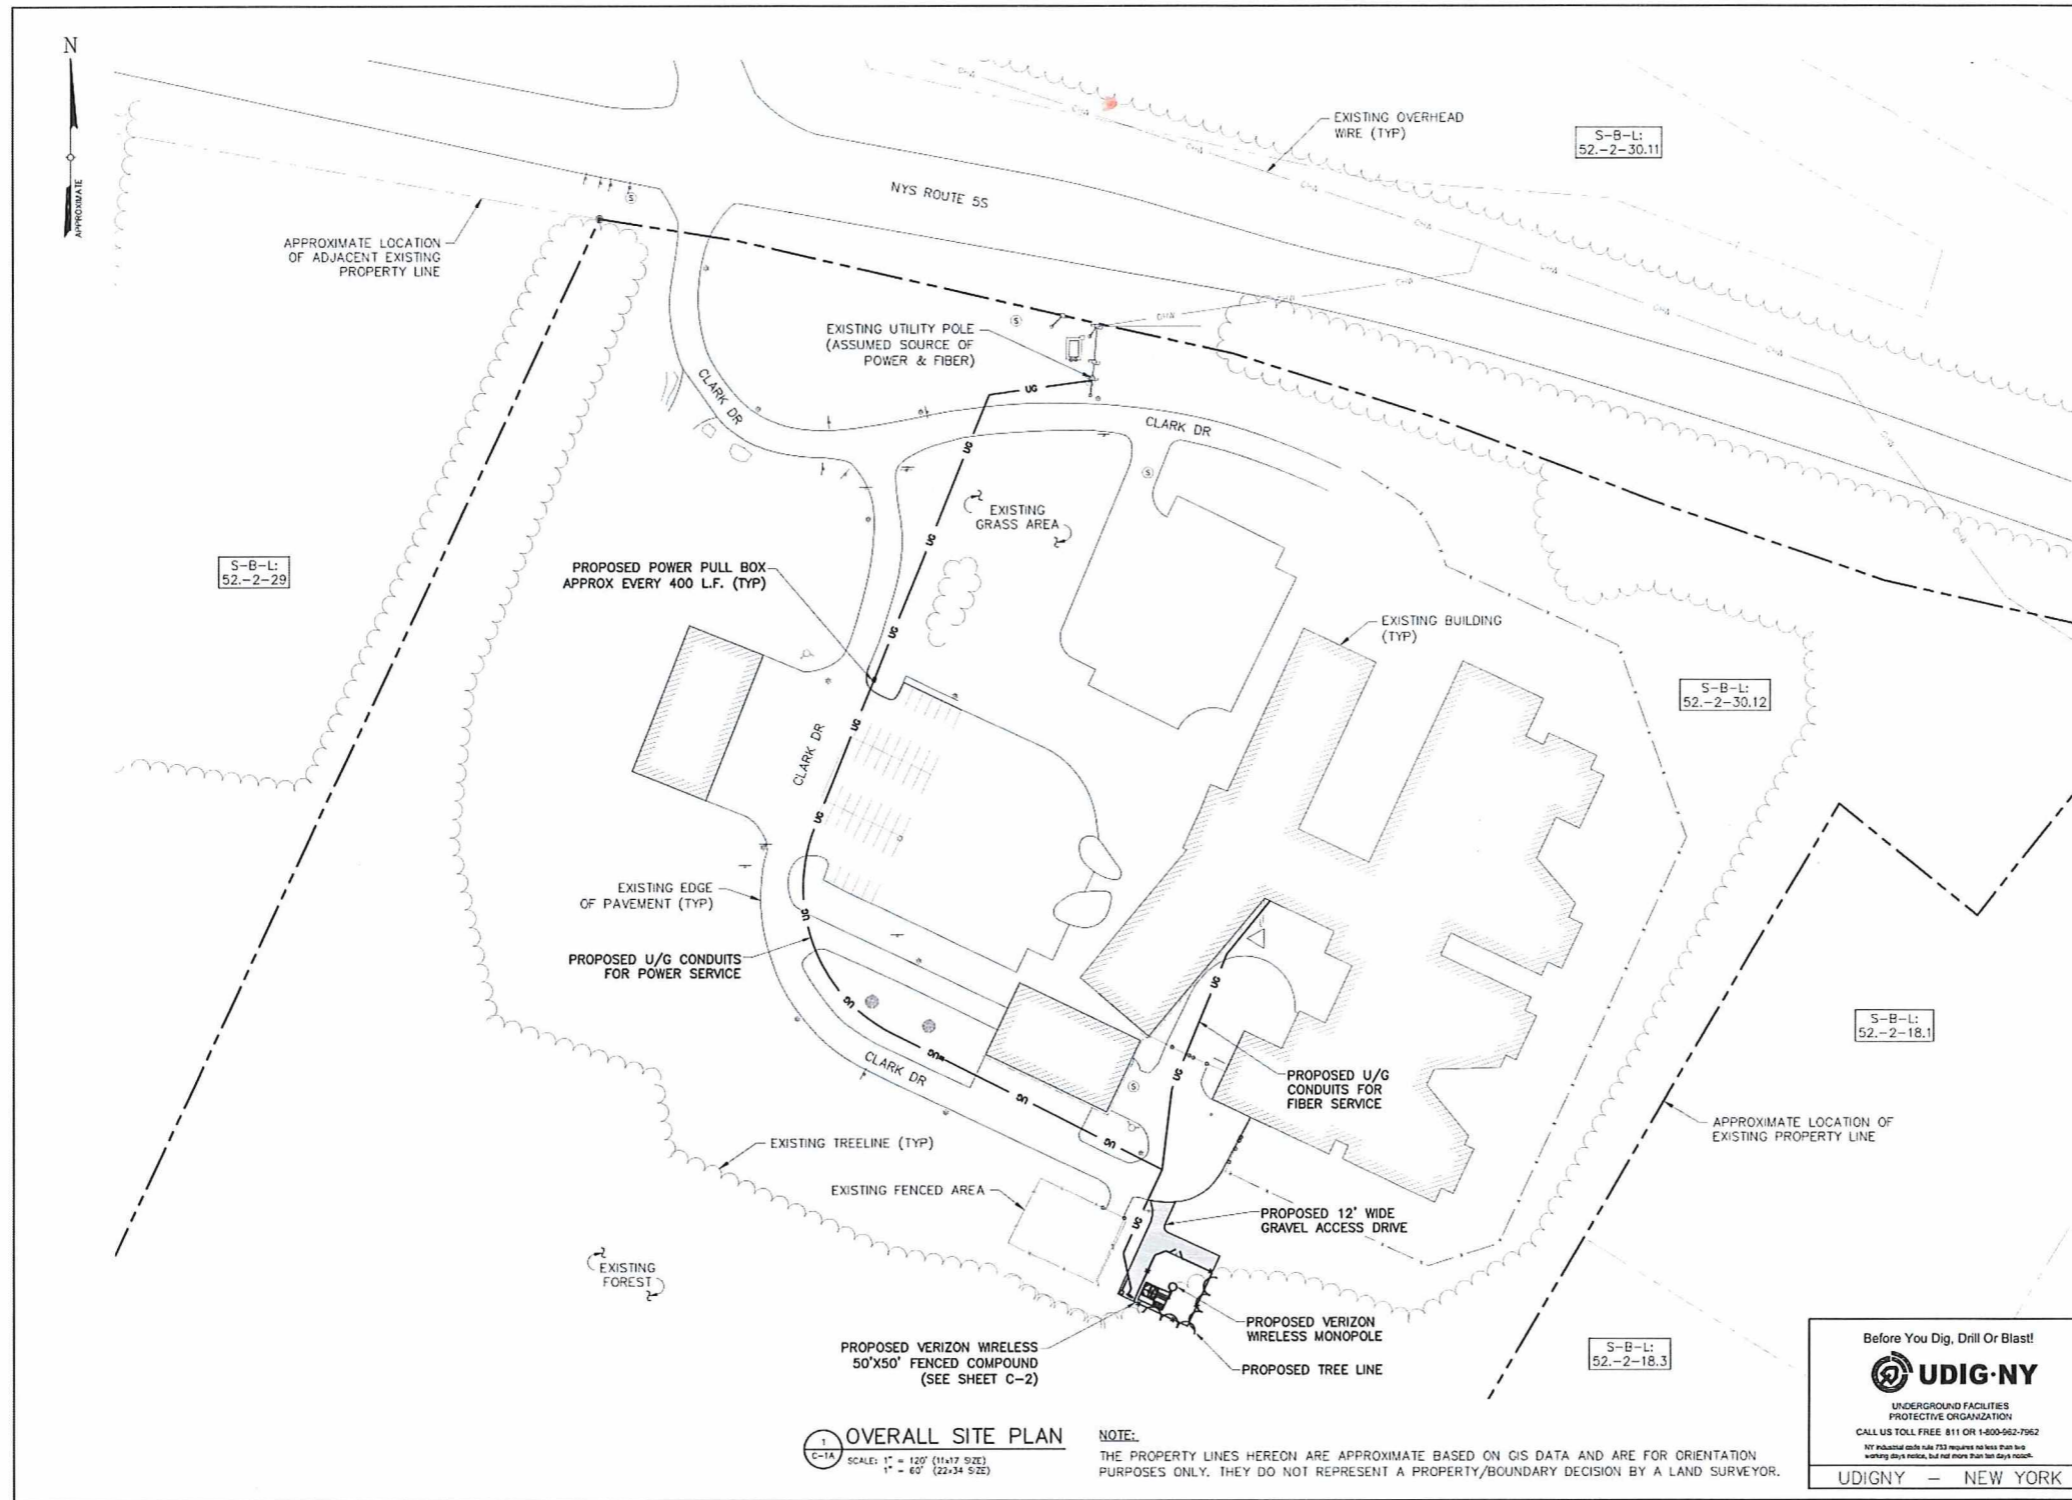

1 OVERALL SITE PLAN
 C-1A
 SCALE: 1" = 120' (11,137 SIZES)
 1" = 60' (22,34 SIZES)

NOTE:
 THE PROPERTY LINES HEREON ARE APPROXIMATE BASED ON GIS DATA AND ARE FOR ORIENTATION PURPOSES ONLY. THEY DO NOT REPRESENT A PROPERTY/BOUNDARY DECISION BY A LAND SURVEYOR.

Before You Dig, Drill Or Blast!

UDIG-NY
 UNDERGROUND FACILITIES
 PROTECTIVE ORGANIZATION
 CALL US TOLL FREE 811 OR 1-800-962-7562
 NY Industrial code rule 233 requires no less than two working days notice, but not more than ten days notice.
 UDIGNY - NEW YORK

verizon
 1275 JOHN STREET, SUITE 100
 WEST HENRIETTA, NY 14586

Tectonic
 PRACTICAL SOLUTIONS. EXCEPTIONAL SERVICE.
 Tectonic Engineering Consultants, Geologic & Land Services, P.C.
 Tectonic Consulting and
 28 Wilson Avenue, Suite 101 Phone: (518) 783-1623
 Loudonville, NY 12110 Fax: (518) 783-6831
 www.tectonicengineering.com

WORK ORDER NUMBER: 11272.075
 DRAWN BY: MQ

NO.	DATE	ISSUE
0	8/1/24	FOR PERMIT

RELEASED BY: _____ DATE: _____



UNAUTHORIZED ALTERATION OR ADDITIONS TO A PLAN BEARING THE SEAL OF A LICENSED ENGINEER OR LAND SURVEYOR IS A VIOLATION OF SECTION 2029 SUBSECTION 2 OF THE NEW YORK STATE EDUCATION LAW.
 COPIES OF THIS DOCUMENT WITHOUT A FACSIMILE OF THE SIGNATURE AND AN ORIGINAL EMBOSSED SEAL OR ORIGINAL STAMP IN BLUE OR RED INK OF THE PROFESSIONAL ENGINEER OR LAND SURVEYOR SHALL NOT BE CONSIDERED VALID COPIES.

ORIGINAL SIZE IN INCHES

SITE INFORMATION
 AURIESVILLE
 FUZE PN: 17134169
 MDG#: 5000012652
 SITE ADDRESS

200 CLARK DRIVE
 TOWN OF GLEN
 MONTGOMERY COUNTY
 NY 12072

SHEET TITLE
 OVERALL SITE PLAN

SHEET NUMBER

C-1A